


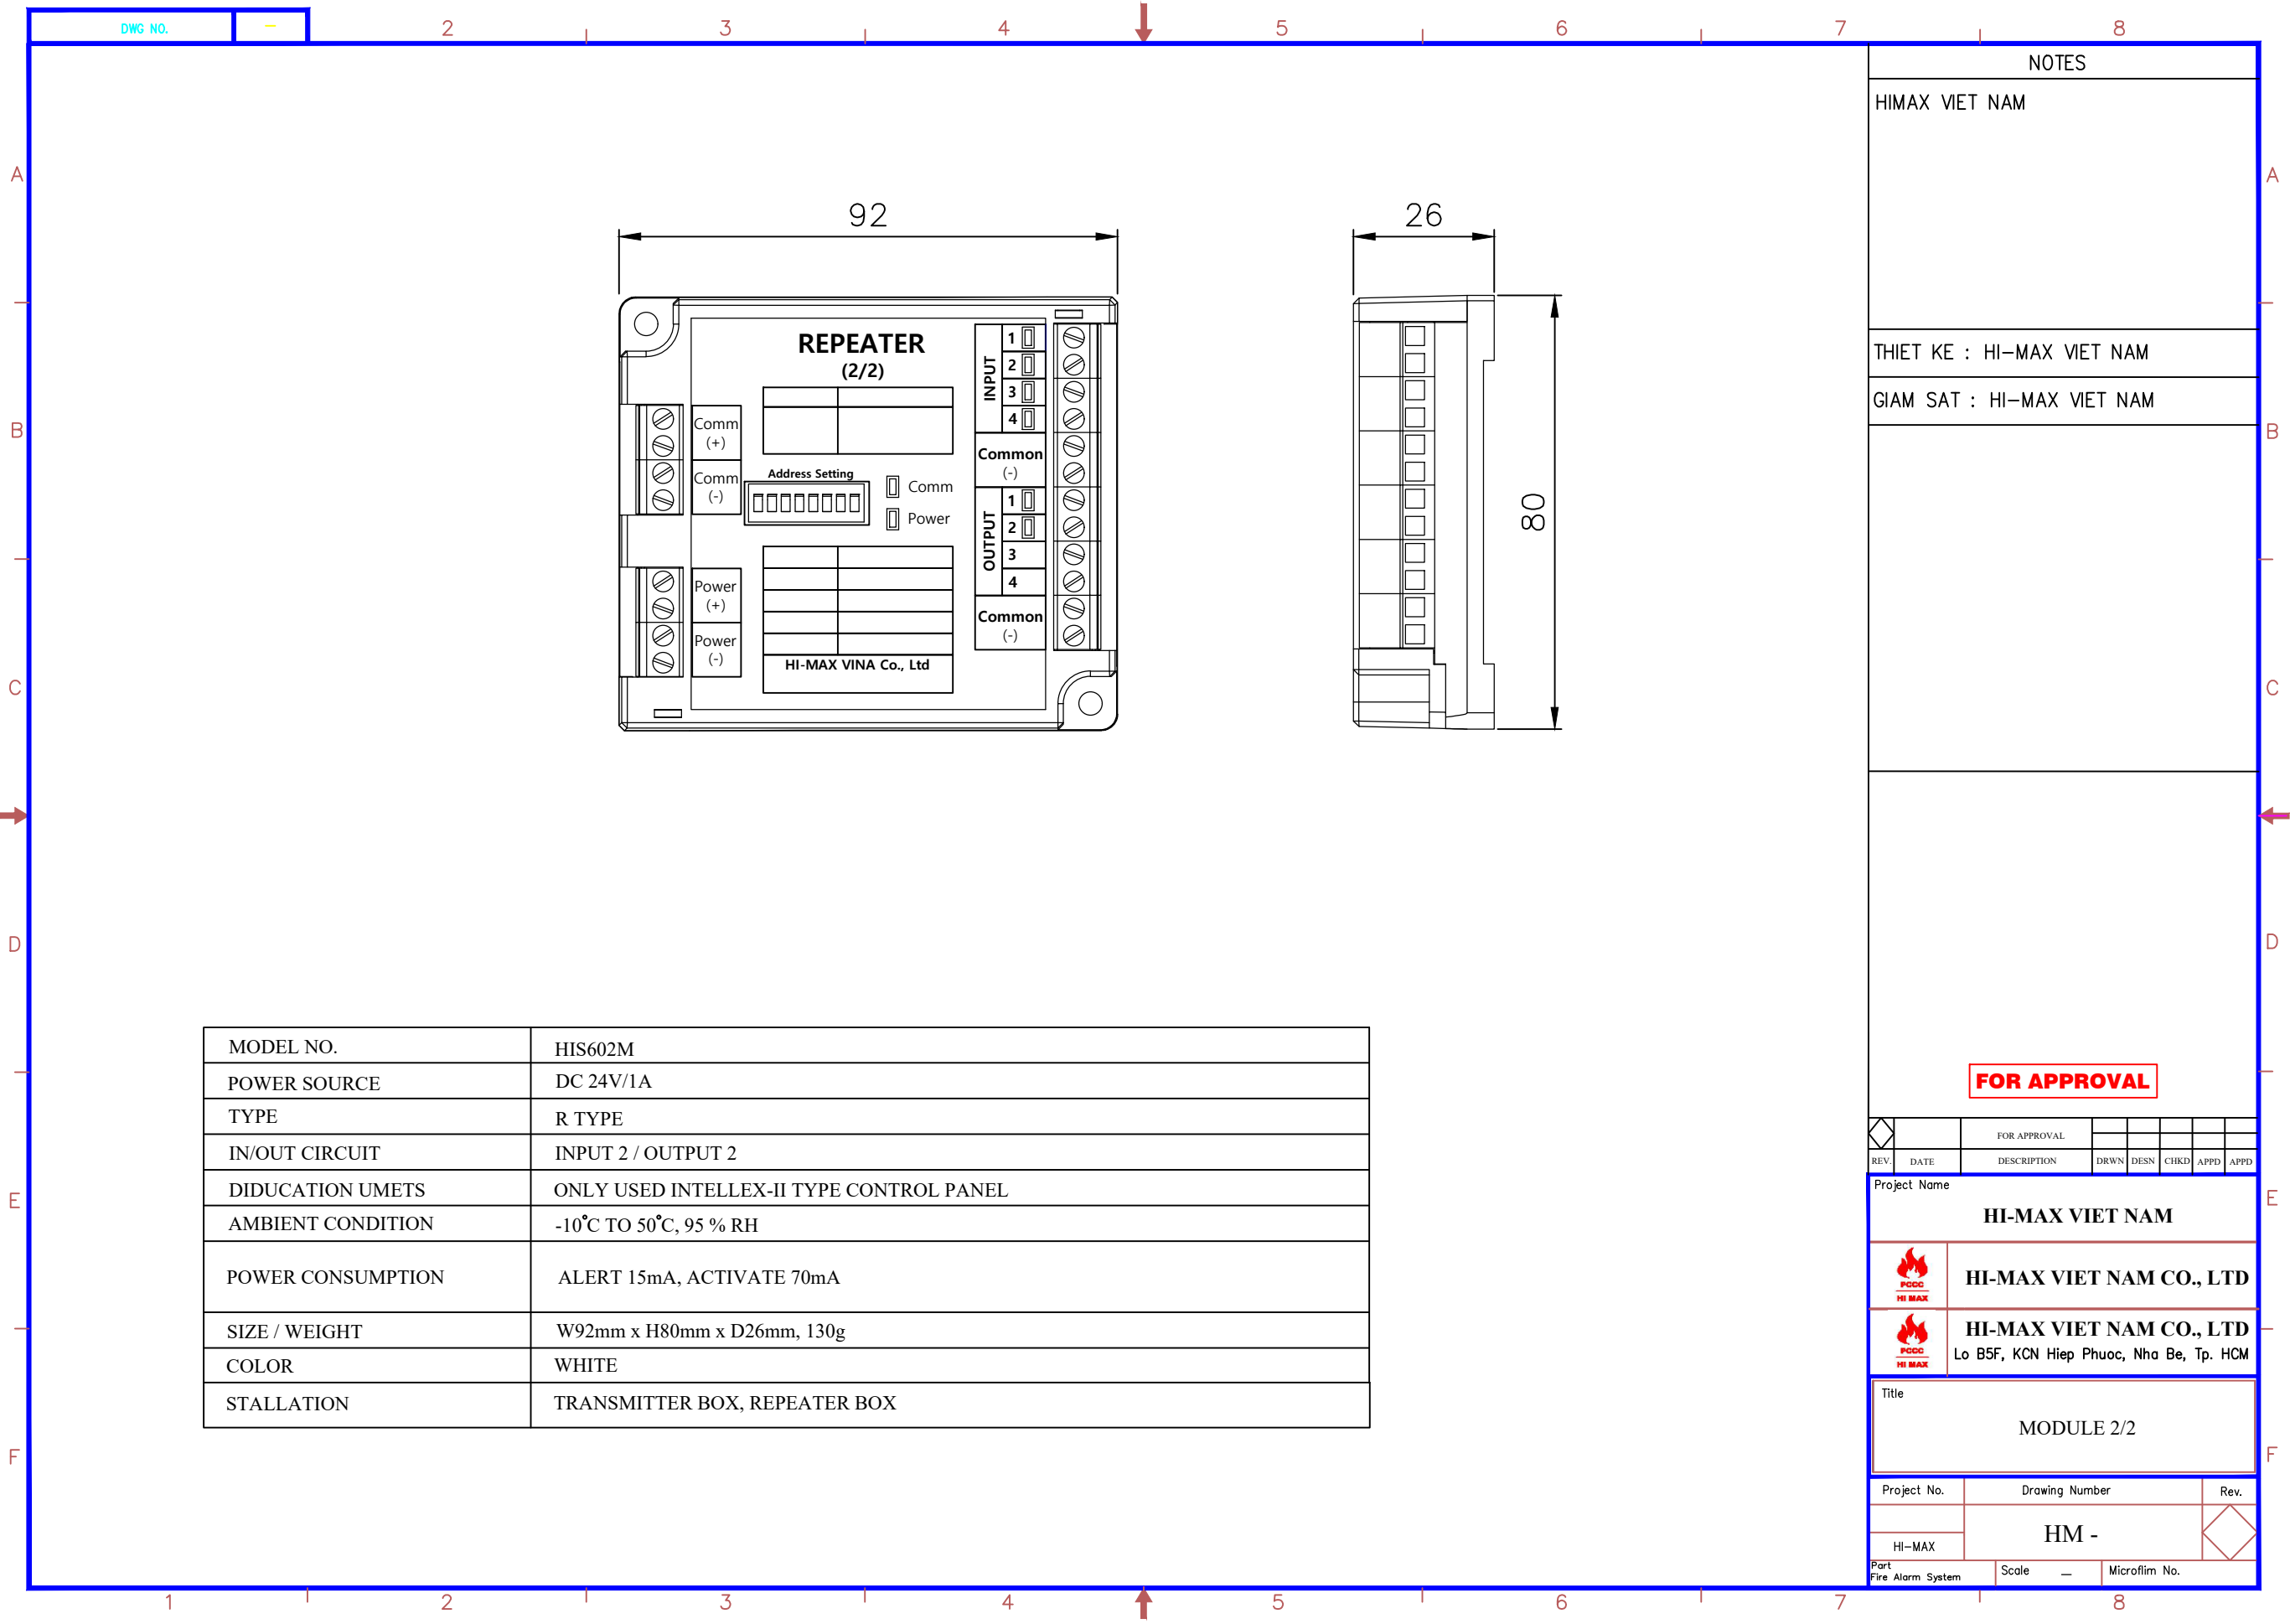

MODEL NO.	HIS602M
POWER SOURCE	DC 24V/1A
TYPE	R TYPE
IN/OUT CIRCUIT	INPUT 2 / OUTPUT 2
DIDUCATION UMETS	ONLY USED INTELLEX-II TYPE CONTROL PANEL
AMBIENT CONDITION	-10°C TO 50°C, 95 % RH
POWER CONSUMPTION	ALERT 15mA, ACTIVATE 70mA
SIZE / WEIGHT	W92mm x H80mm x D26mm, 130g
COLOR	WHITE
STALLATION	TRANSMITTER BOX, REPEATER BOX

NOTES

HIMAX VIET NAM

THIET KE : HI-MAX VIET NAM

GIAM SAT : HI-MAX VIET NAM

FOR APPROVAL

REV.	DATE	DESCRIPTION	DRWN	DESN	CHKD	APPD	APPD
Project Name							
HI-MAX VIET NAM							
		HI-MAX VIET NAM CO., LTD					
		HI-MAX VIET NAM CO., LTD Lo B5F, KCN Hiep Phuoc, Nha Be, Tp. HCM					
Title							
MODULE 2/2							
Project No.		Drawing Number				Rev.	
HI-MAX		HM -					
Part Fire Alarm System		Scale —		Microfilm No.			