


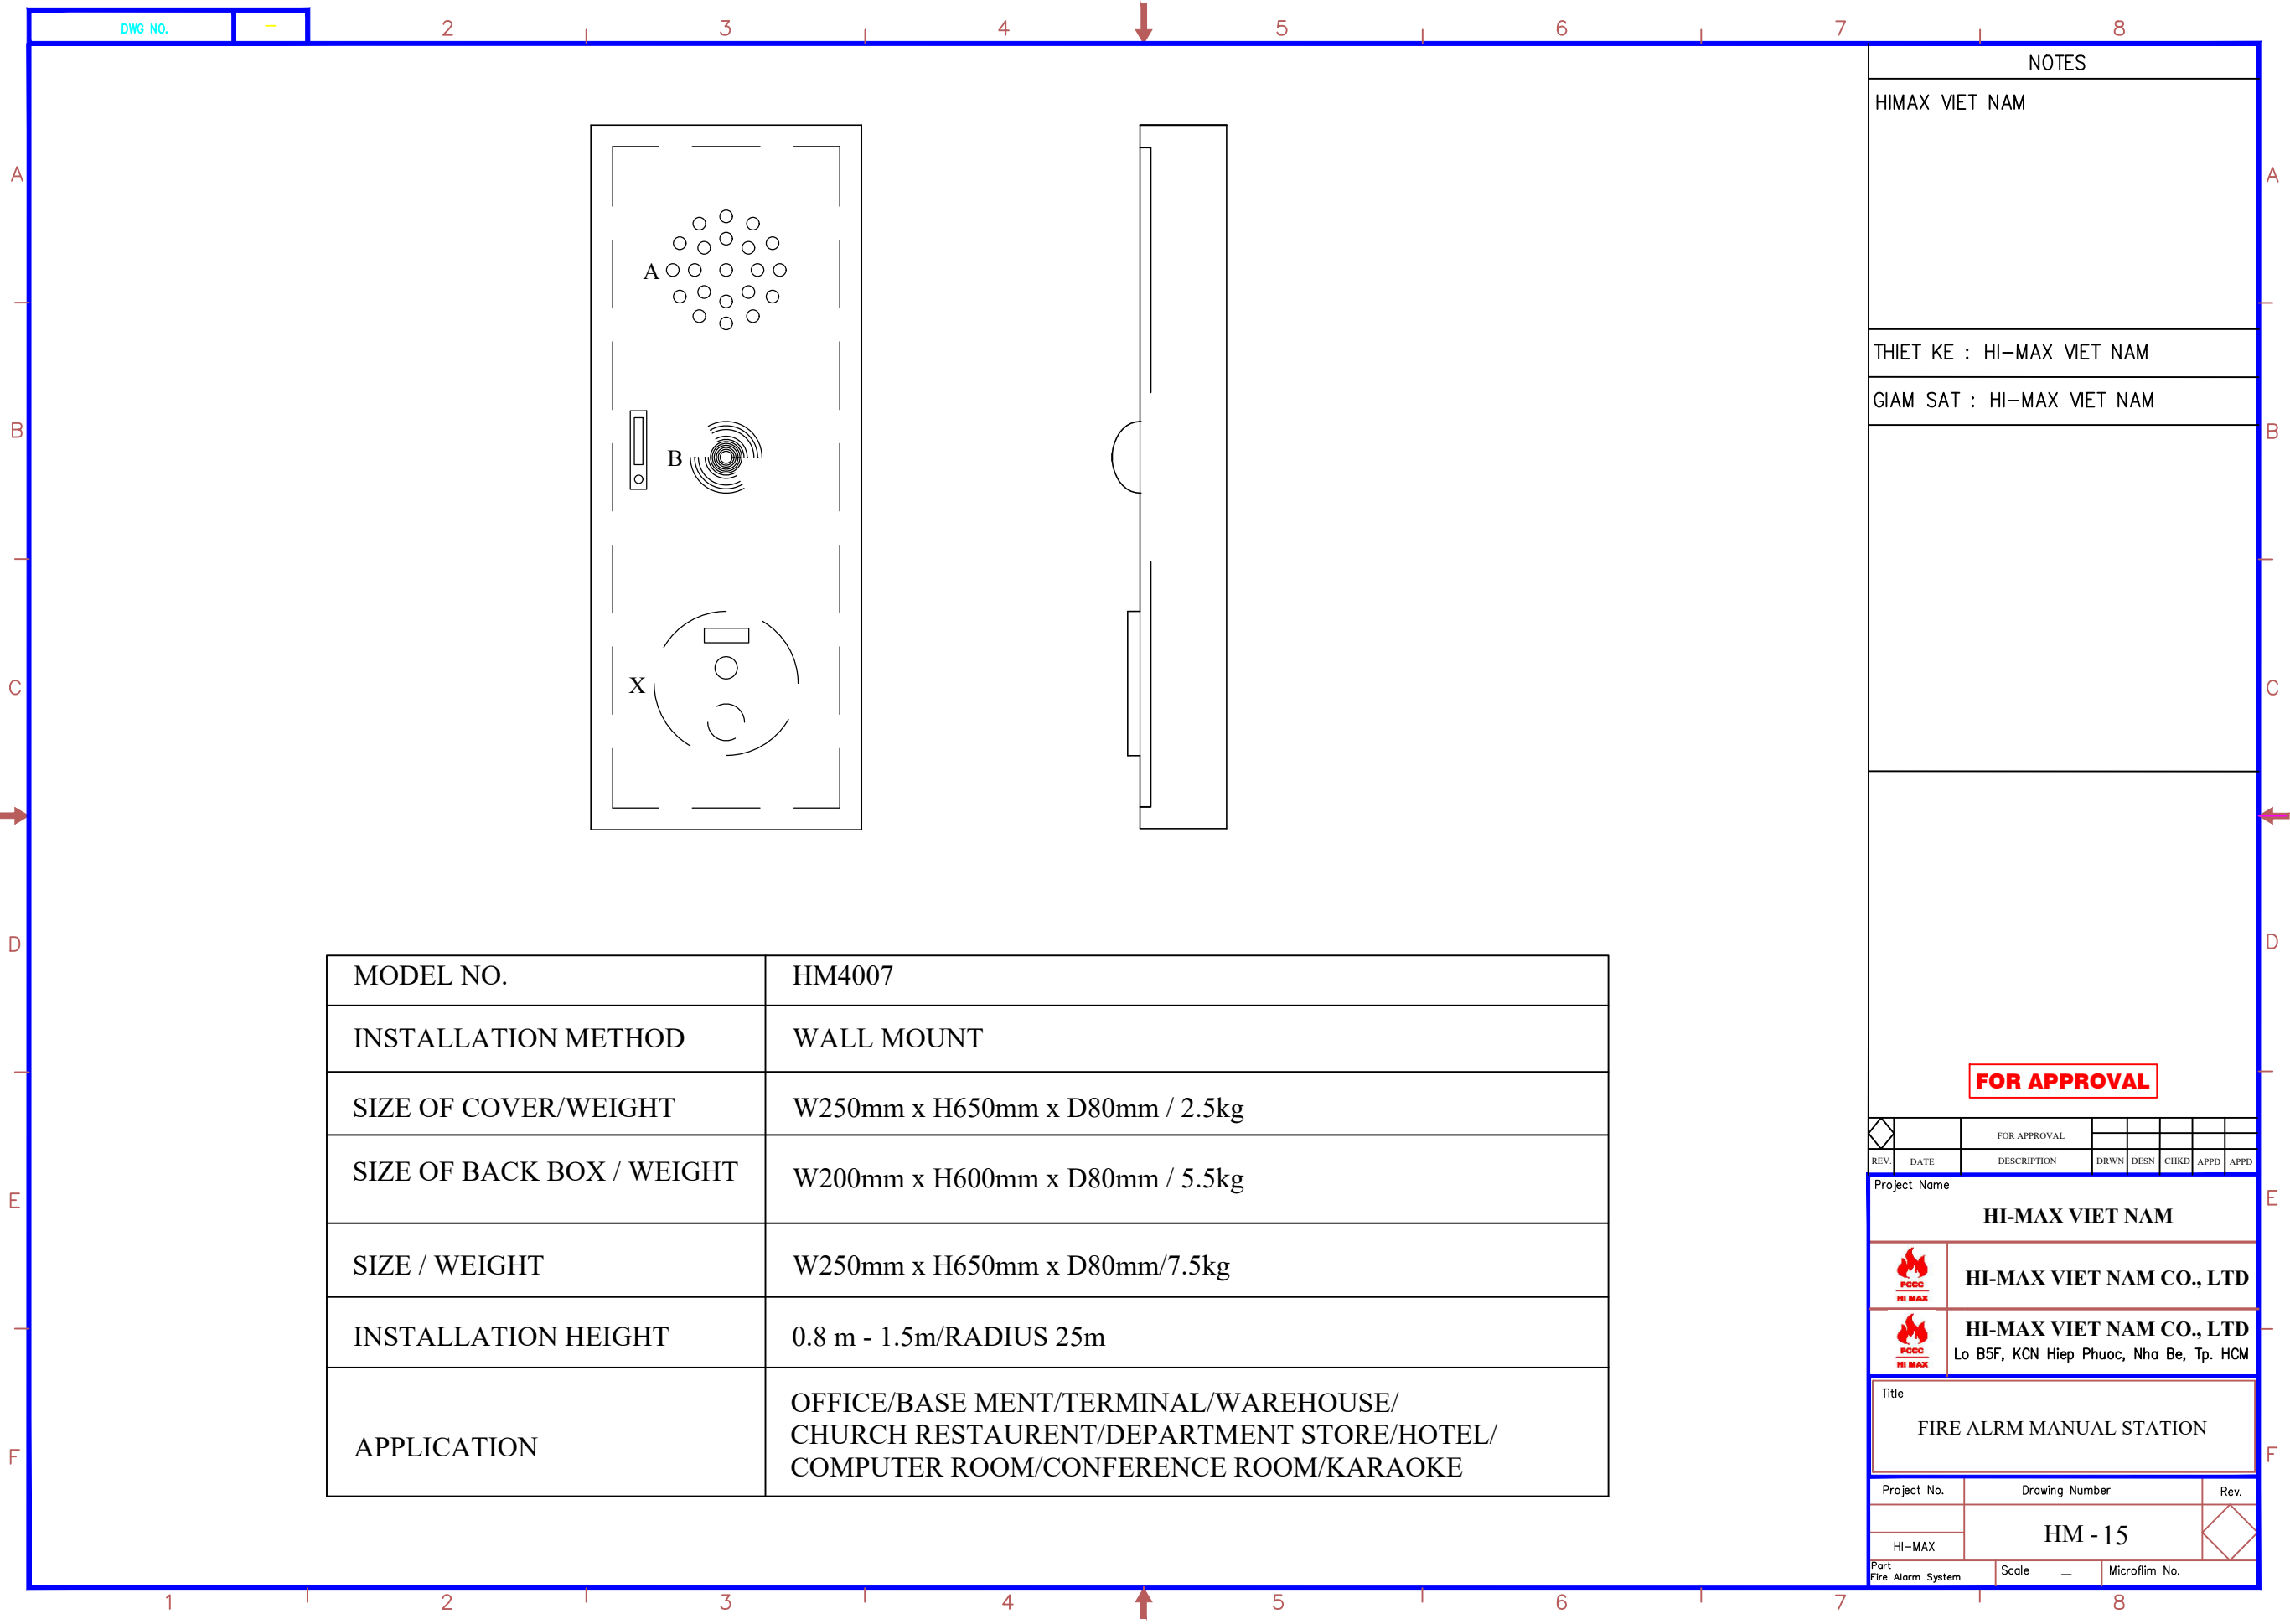

MODEL NO.	HM4007
INSTALLATION METHOD	WALL MOUNT
SIZE OF COVER/WEIGHT	W250mm x H650mm x D80mm / 2.5kg
SIZE OF BACK BOX / WEIGHT	W200mm x H600mm x D80mm / 5.5kg
SIZE / WEIGHT	W250mm x H650mm x D80mm/7.5kg
INSTALLATION HEIGHT	0.8 m - 1.5m/RADIUS 25m
APPLICATION	OFFICE/BASE MENT/TERMINAL/WAREHOUSE/ CHURCH RESTAURENT/DEPARTMENT STORE/HOTEL/ COMPUTER ROOM/CONFERENCE ROOM/KARAOKE

NOTES

HIMAX VIET NAM

THIET KE : HI-MAX VIET NAM

GIAM SAT : HI-MAX VIET NAM

FOR APPROVAL

FOR APPROVAL							
REV.	DATE	DESCRIPTION	DRWN	DESN	CHKD	APPD	APPD

Project Name

HI-MAX VIET NAM

HI-MAX VIET NAM CO., LTD

HI-MAX VIET NAM CO., LTD
Lo B5F, KCN Hiep Phuoc, Nha Be, Tp. HCM

Title

FIRE ALRM MANUAL STATION

Project No.	Drawing Number	Rev.
	HM - 15	
Part Fire Alarm System	Scale —	Microfilm No.