


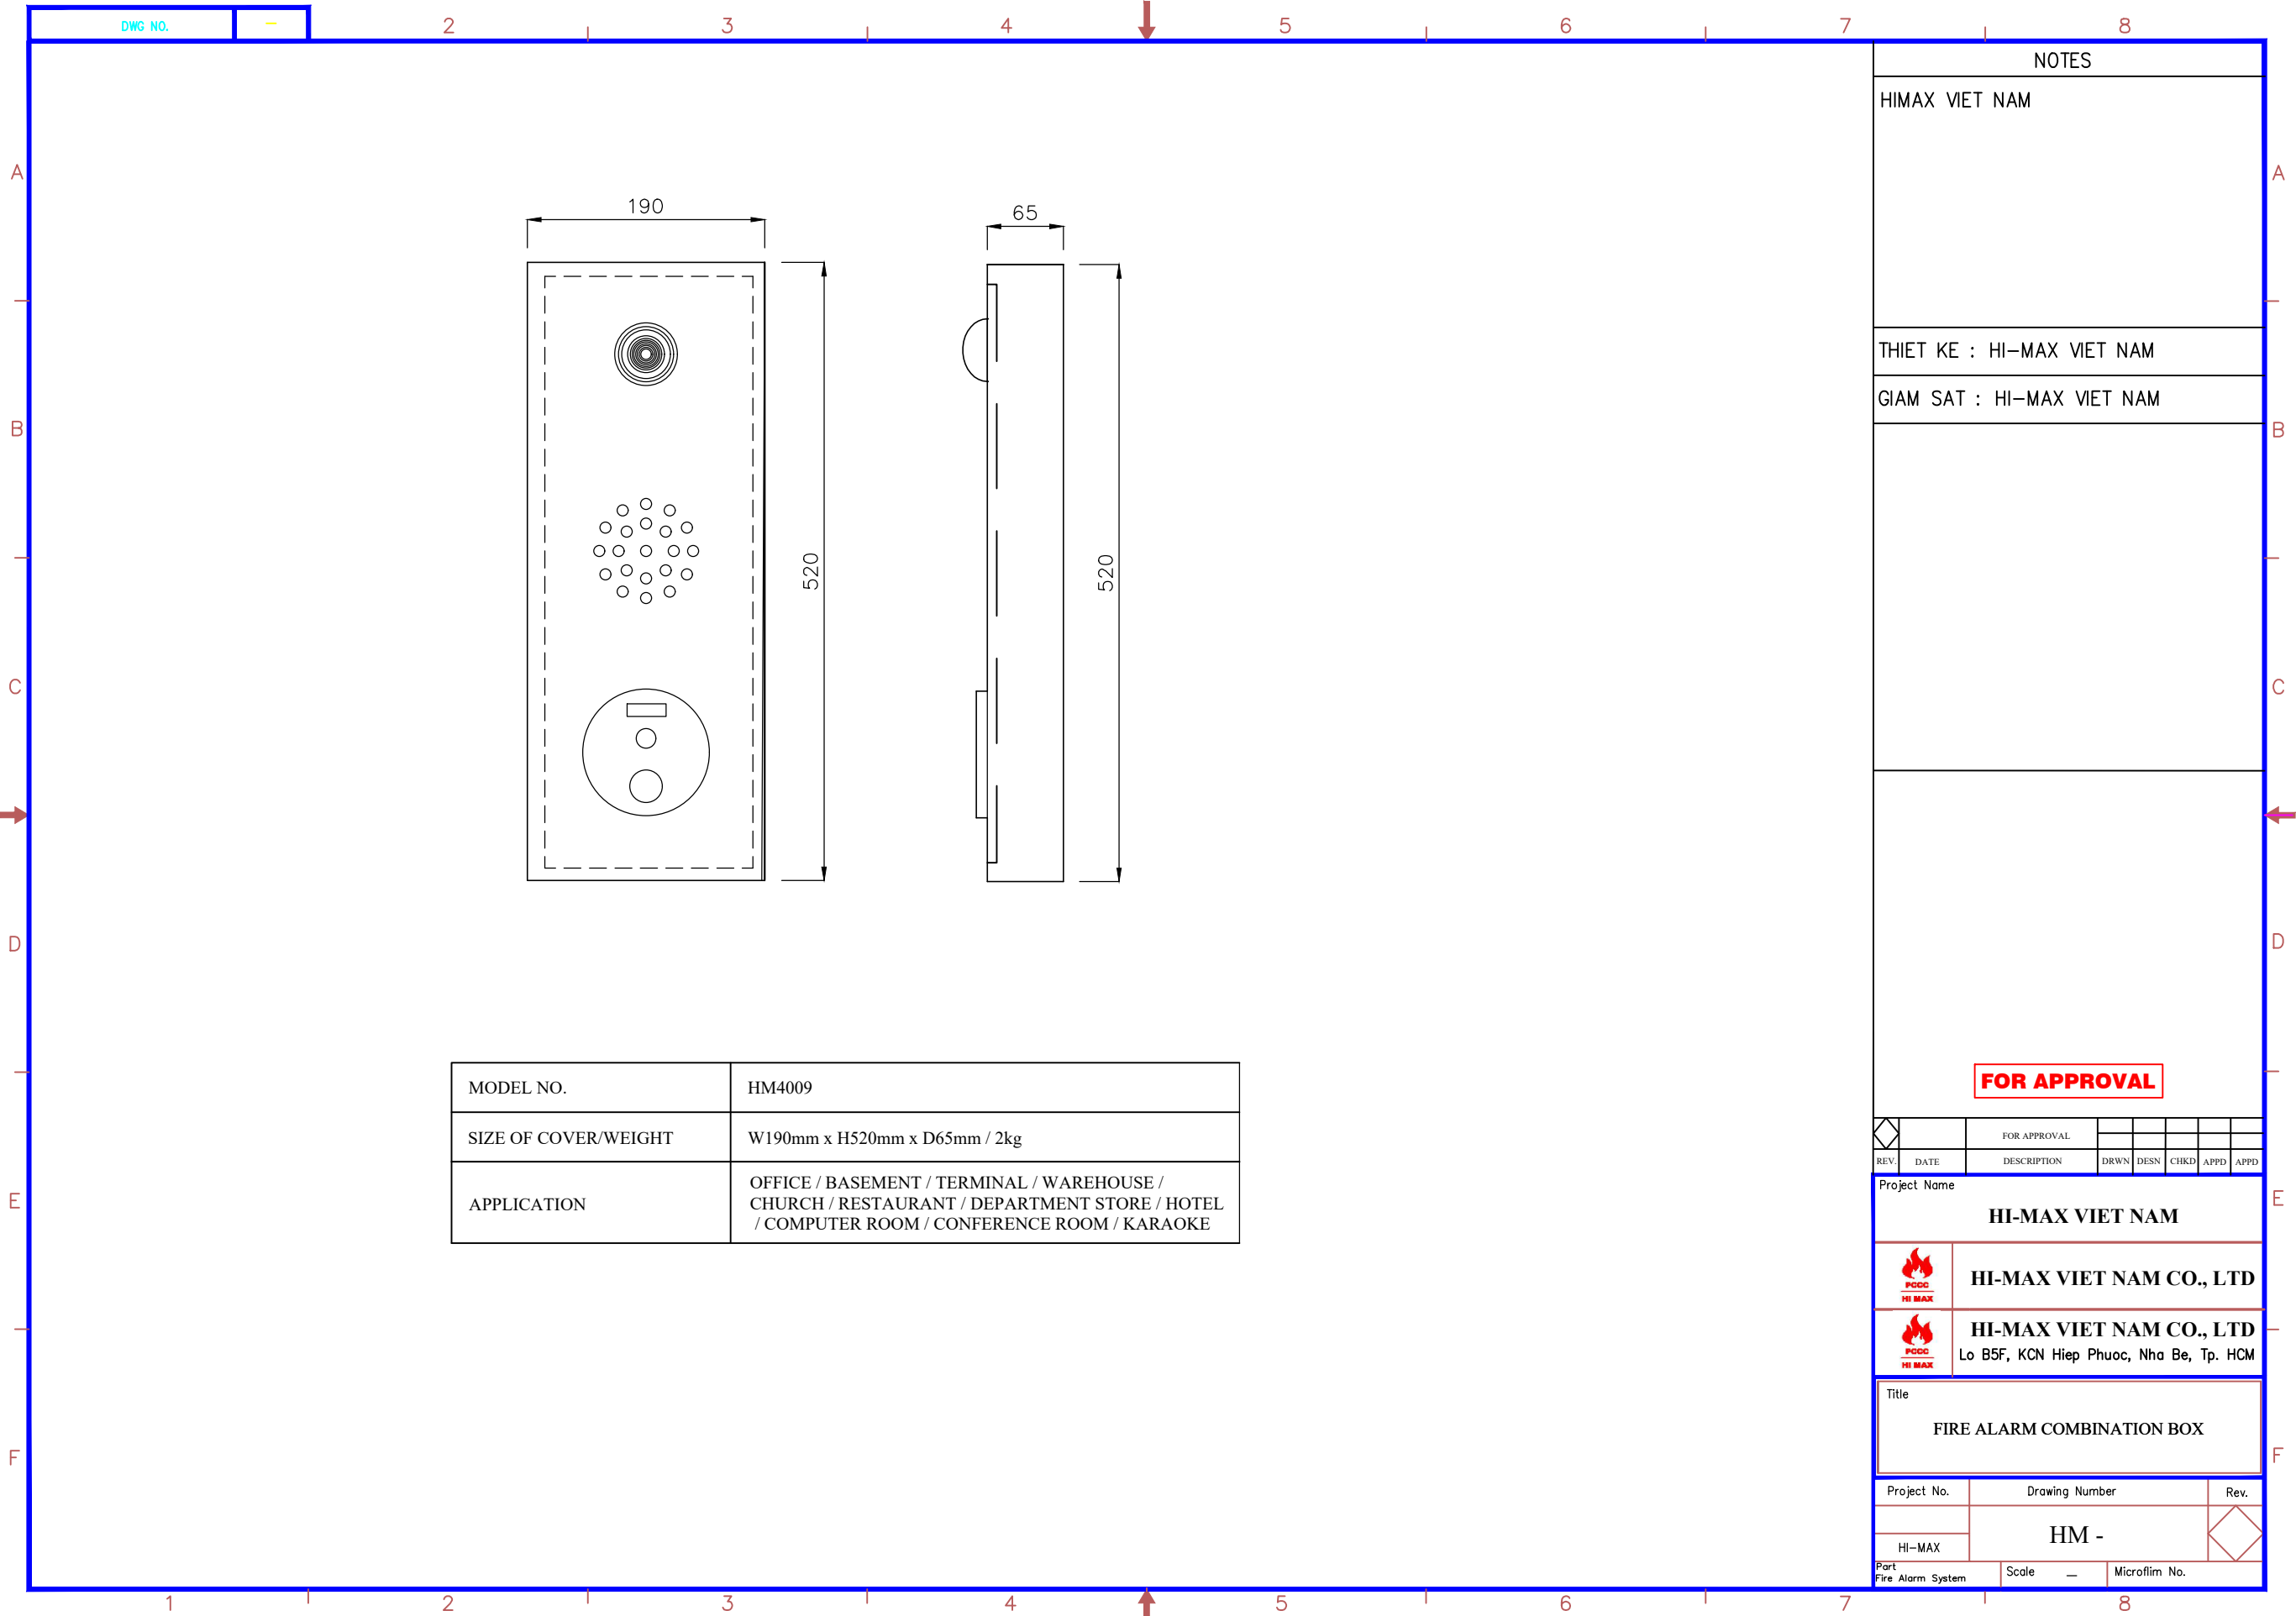

MODEL NO.	HM4009
SIZE OF COVER/WEIGHT	W190mm x H520mm x D65mm / 2kg
APPLICATION	OFFICE / BASEMENT / TERMINAL / WAREHOUSE / CHURCH / RESTAURANT / DEPARTMENT STORE / HOTEL / COMPUTER ROOM / CONFERENCE ROOM / KARAOKE

NOTES

HIMAX VIET NAM

THIET KE : HI-MAX VIET NAM

GIAM SAT : HI-MAX VIET NAM

FOR APPROVAL

		FOR APPROVAL					
REV.	DATE	DESCRIPTION	DRWN	DESN	CHKD	APPD	APPD

Project Name

HI-MAX VIET NAM

HI-MAX VIET NAM CO., LTD

HI-MAX VIET NAM CO., LTD
Lo B5F, KCN Hiep Phuoc, Nha Be, Tp. HCM

Title

FIRE ALARM COMBINATION BOX

Project No.	Drawing Number	Rev.
	HM -	
Part Fire Alarm System	Scale —	Microfilm No.